

| Rev. | Date | Revisions |
|------|----------|--|
| 0 | 14.03.02 | SMOKE DETECTORS ADDED IN MARK OFFICE AREA AS DUPLICATES OF UNITS SHOWN ON POWER & AUXILIARY DRAWINGS |
| 1 | 14.03.02 | REVISIONS |
| 2 | 14.12.01 | LIGHTING FITTING REFERENCES CHANGED TO ACCORD WITH REVISED SCHEDULE LISTING LIGHT RECEAILED, DRICAT UNITS ADDED. |
| A | 16.03.01 | |


BRUNEL
 ENGINEERING CONSULTANTS LTD
 1 Gloucester Row
 Clifton
 Bristol BS8 4AW
 TN 0117 973 0325 FX 0117 973 1857

Contract
REEDSPACE LIMITED
 PROPOSED OFFICE DEVELOPMENT
 EASTERN ROAD, BRACKNELL

Drawing Title
UNIT L - GROUND FLOOR LIGHTING SERVICES
 15.2.02

Drawing Status
TENDER/CONTRACT
 Date: DEC 2000 Scale: 1 : 50
 Drawing Number
9193/LGF/E2

Rev.
D

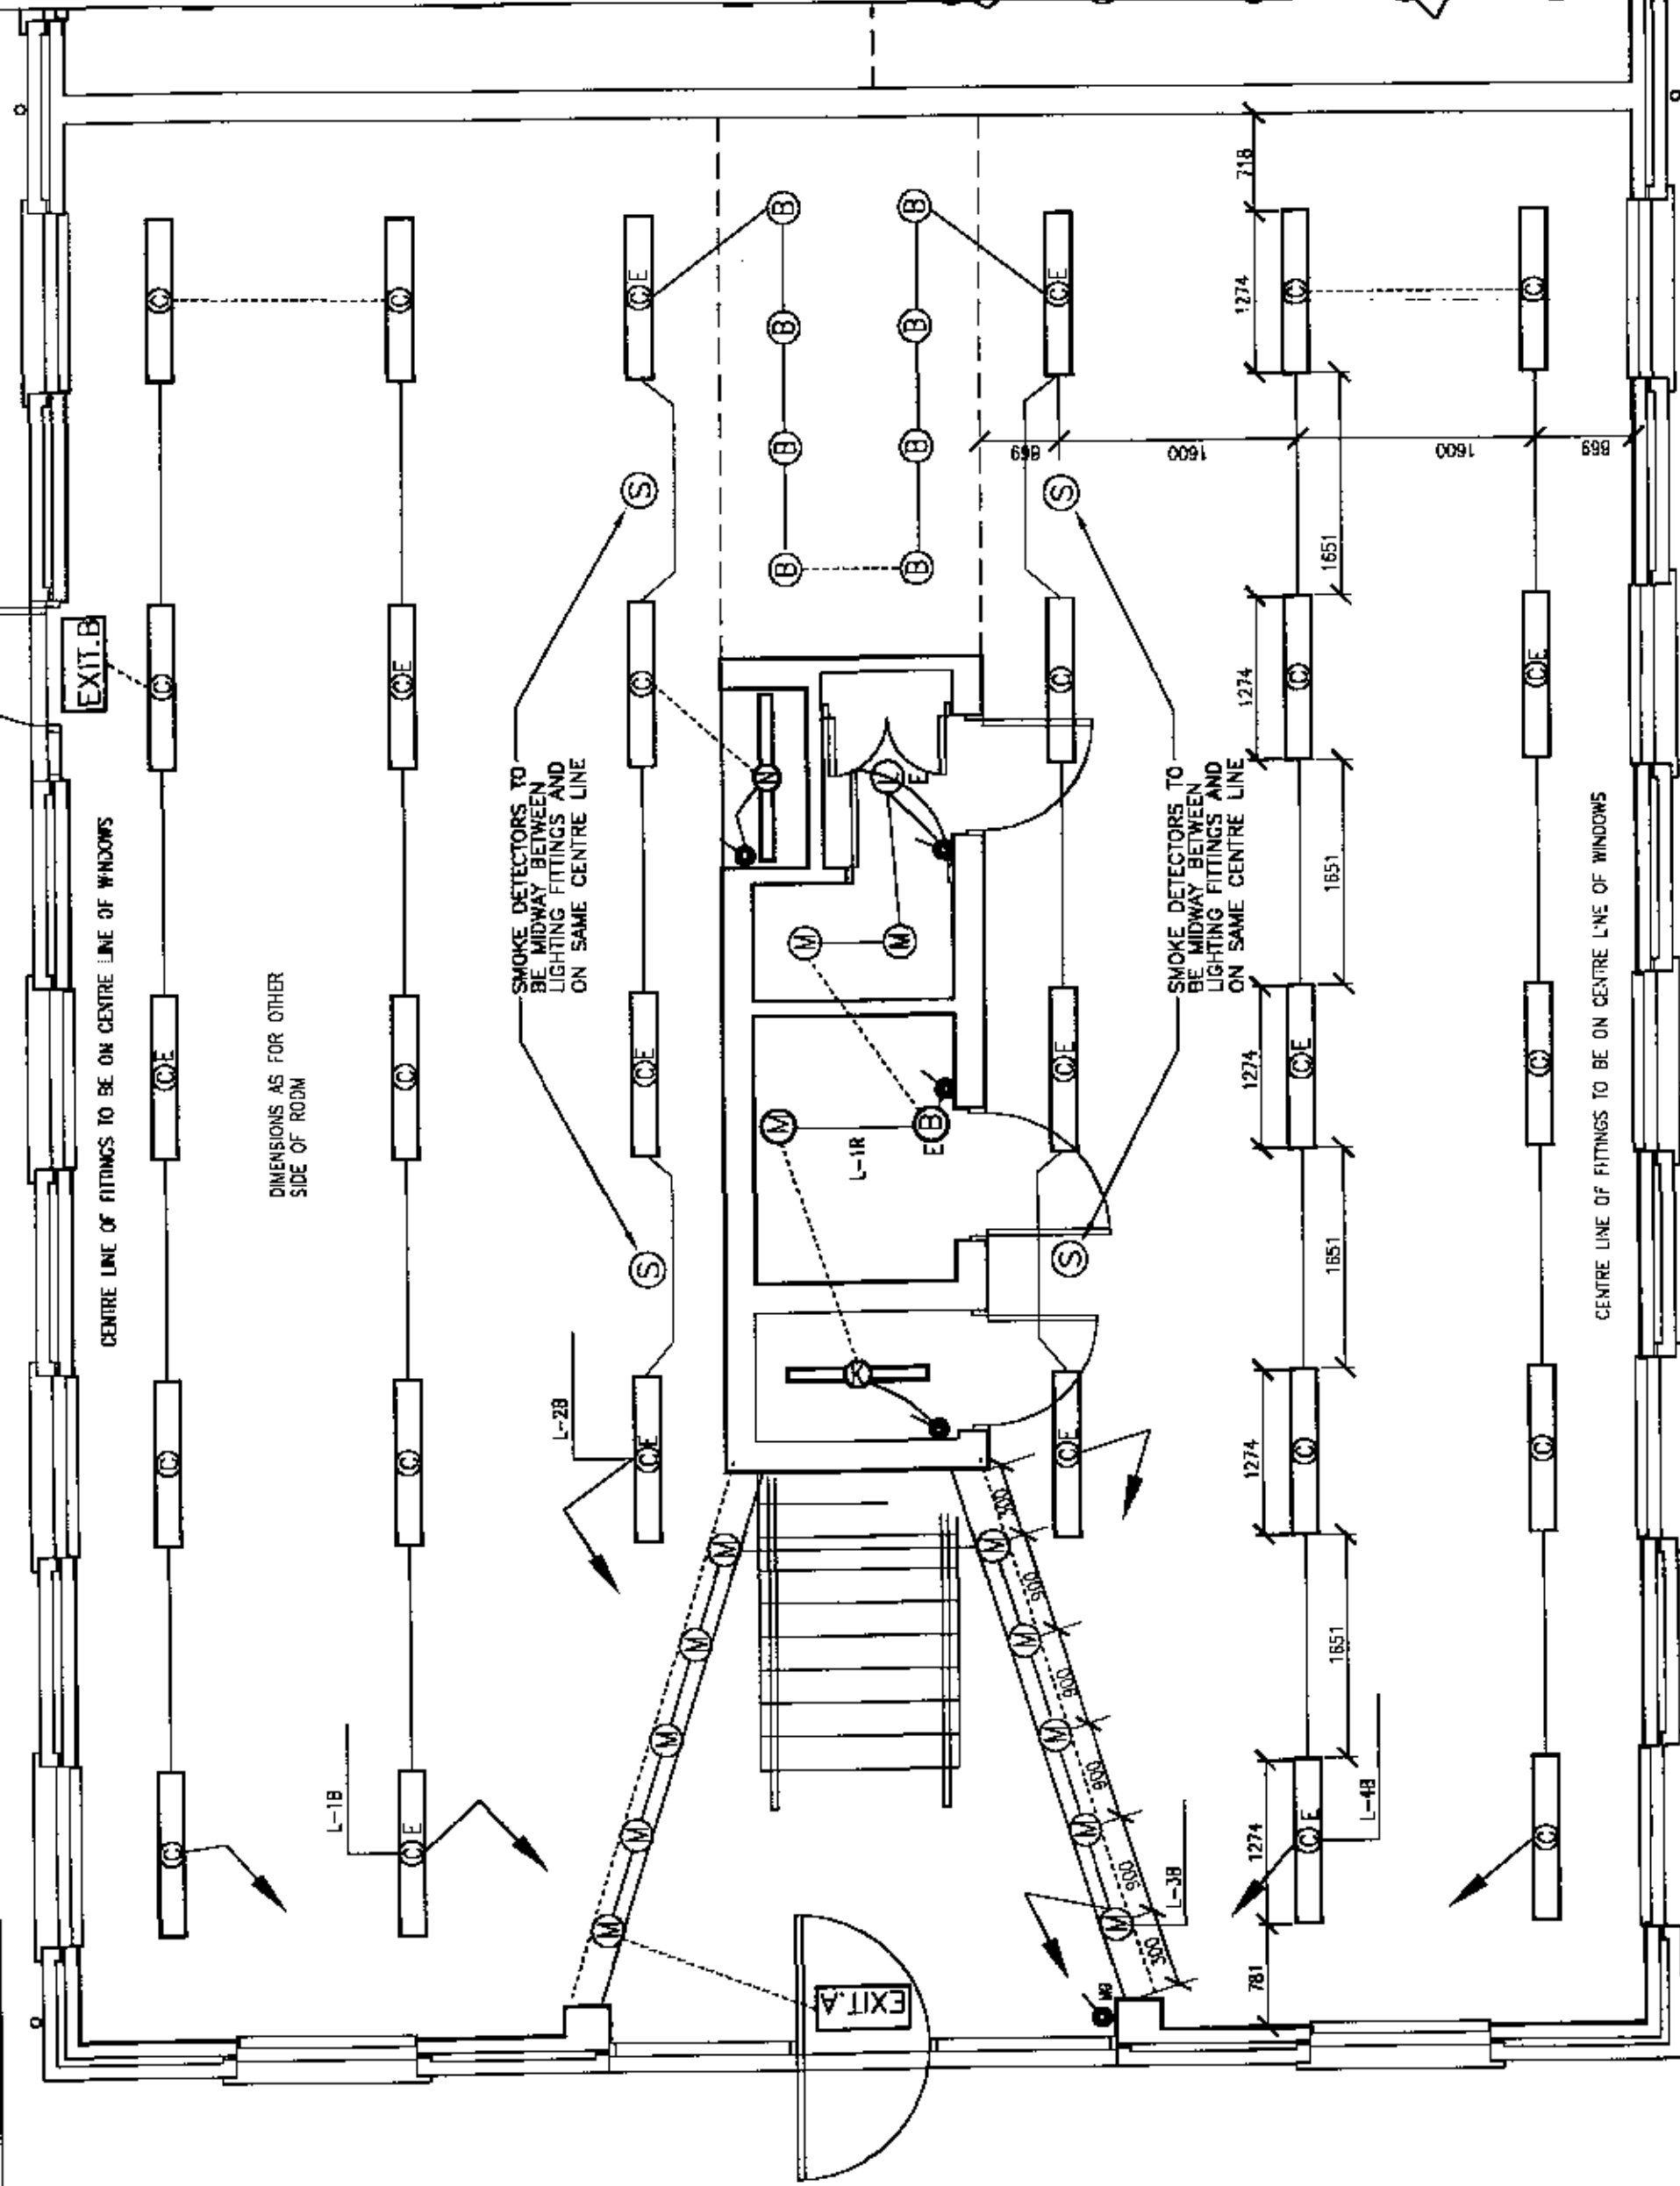

UNIT L - GROUND FLOOR PLAN