

Rev.	Date	Revision
1	12.03.02	CONTRACT AWARDED
2	12.12.01	REF. TO BRUNEL CONSULTANTS LTD
3	12.03.01	REF. TO BRUNEL CONSULTANTS LTD
4	12.03.01	REF. TO BRUNEL CONSULTANTS LTD
5	12.03.01	REF. TO BRUNEL CONSULTANTS LTD
6	12.03.01	REF. TO BRUNEL CONSULTANTS LTD
7	12.03.01	REF. TO BRUNEL CONSULTANTS LTD
8	12.03.01	REF. TO BRUNEL CONSULTANTS LTD
9	12.03.01	REF. TO BRUNEL CONSULTANTS LTD
10	12.03.01	REF. TO BRUNEL CONSULTANTS LTD

**BRUNEL**  
ENGINEERING CONSULTANTS LTD  
1 Gloucester Row  
Clifton  
Bristol BS8 4AW  
TN. 0117 973 0635 FX. 0117 973 1897


Contract  
**REEDSPACE LIMITED**  
PROPOSED OFFICE DEVELOPMENT  
EASTERN ROAD, BRACKNELL

Drawing Title  
**UNITS H & K - FIRST FLOOR LIGHTING SERVICES**

Drawing Status  
**TENDER/CONTRACT**

Date: DEC. 2002 Scale: 1:50  
Drawing Number  
**9183M-KIFFE2**  
Rev. **C**

25.1.02

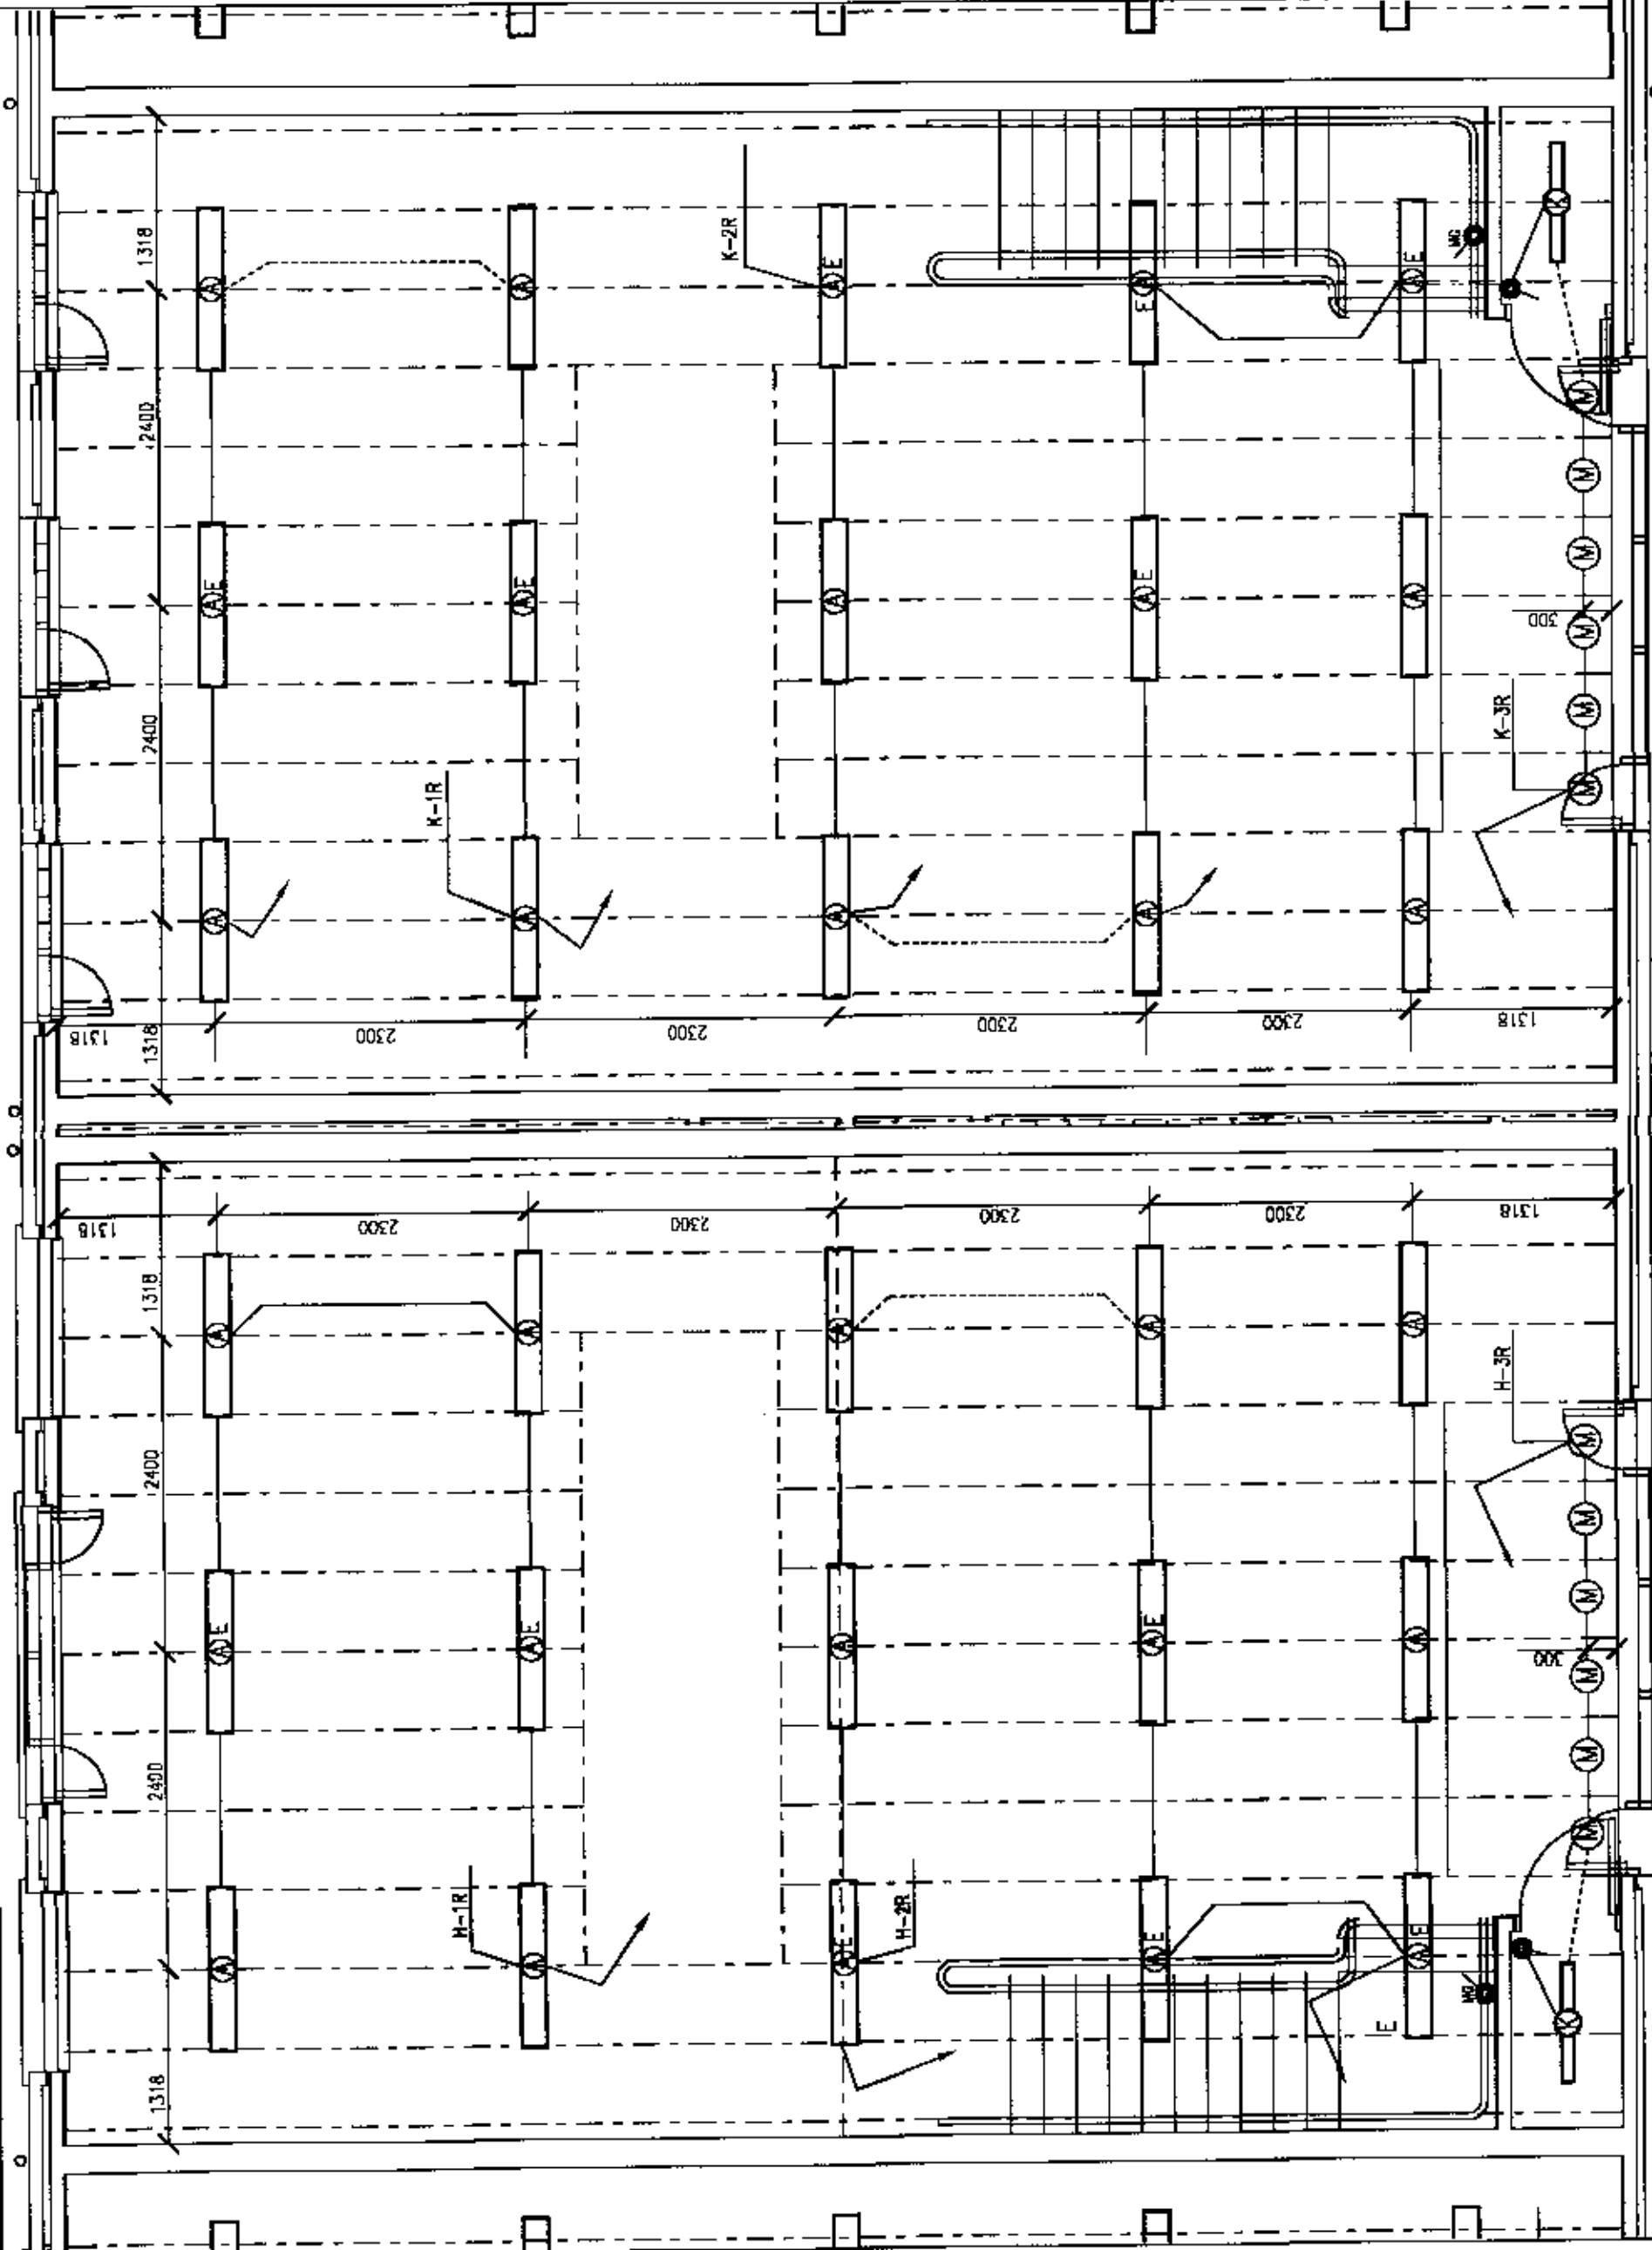

UNIT K - FIRST FLOOR PLAN

UNIT H - FIRST FLOOR PLAN