


UNIT K - GROUND FLOOR PLAN

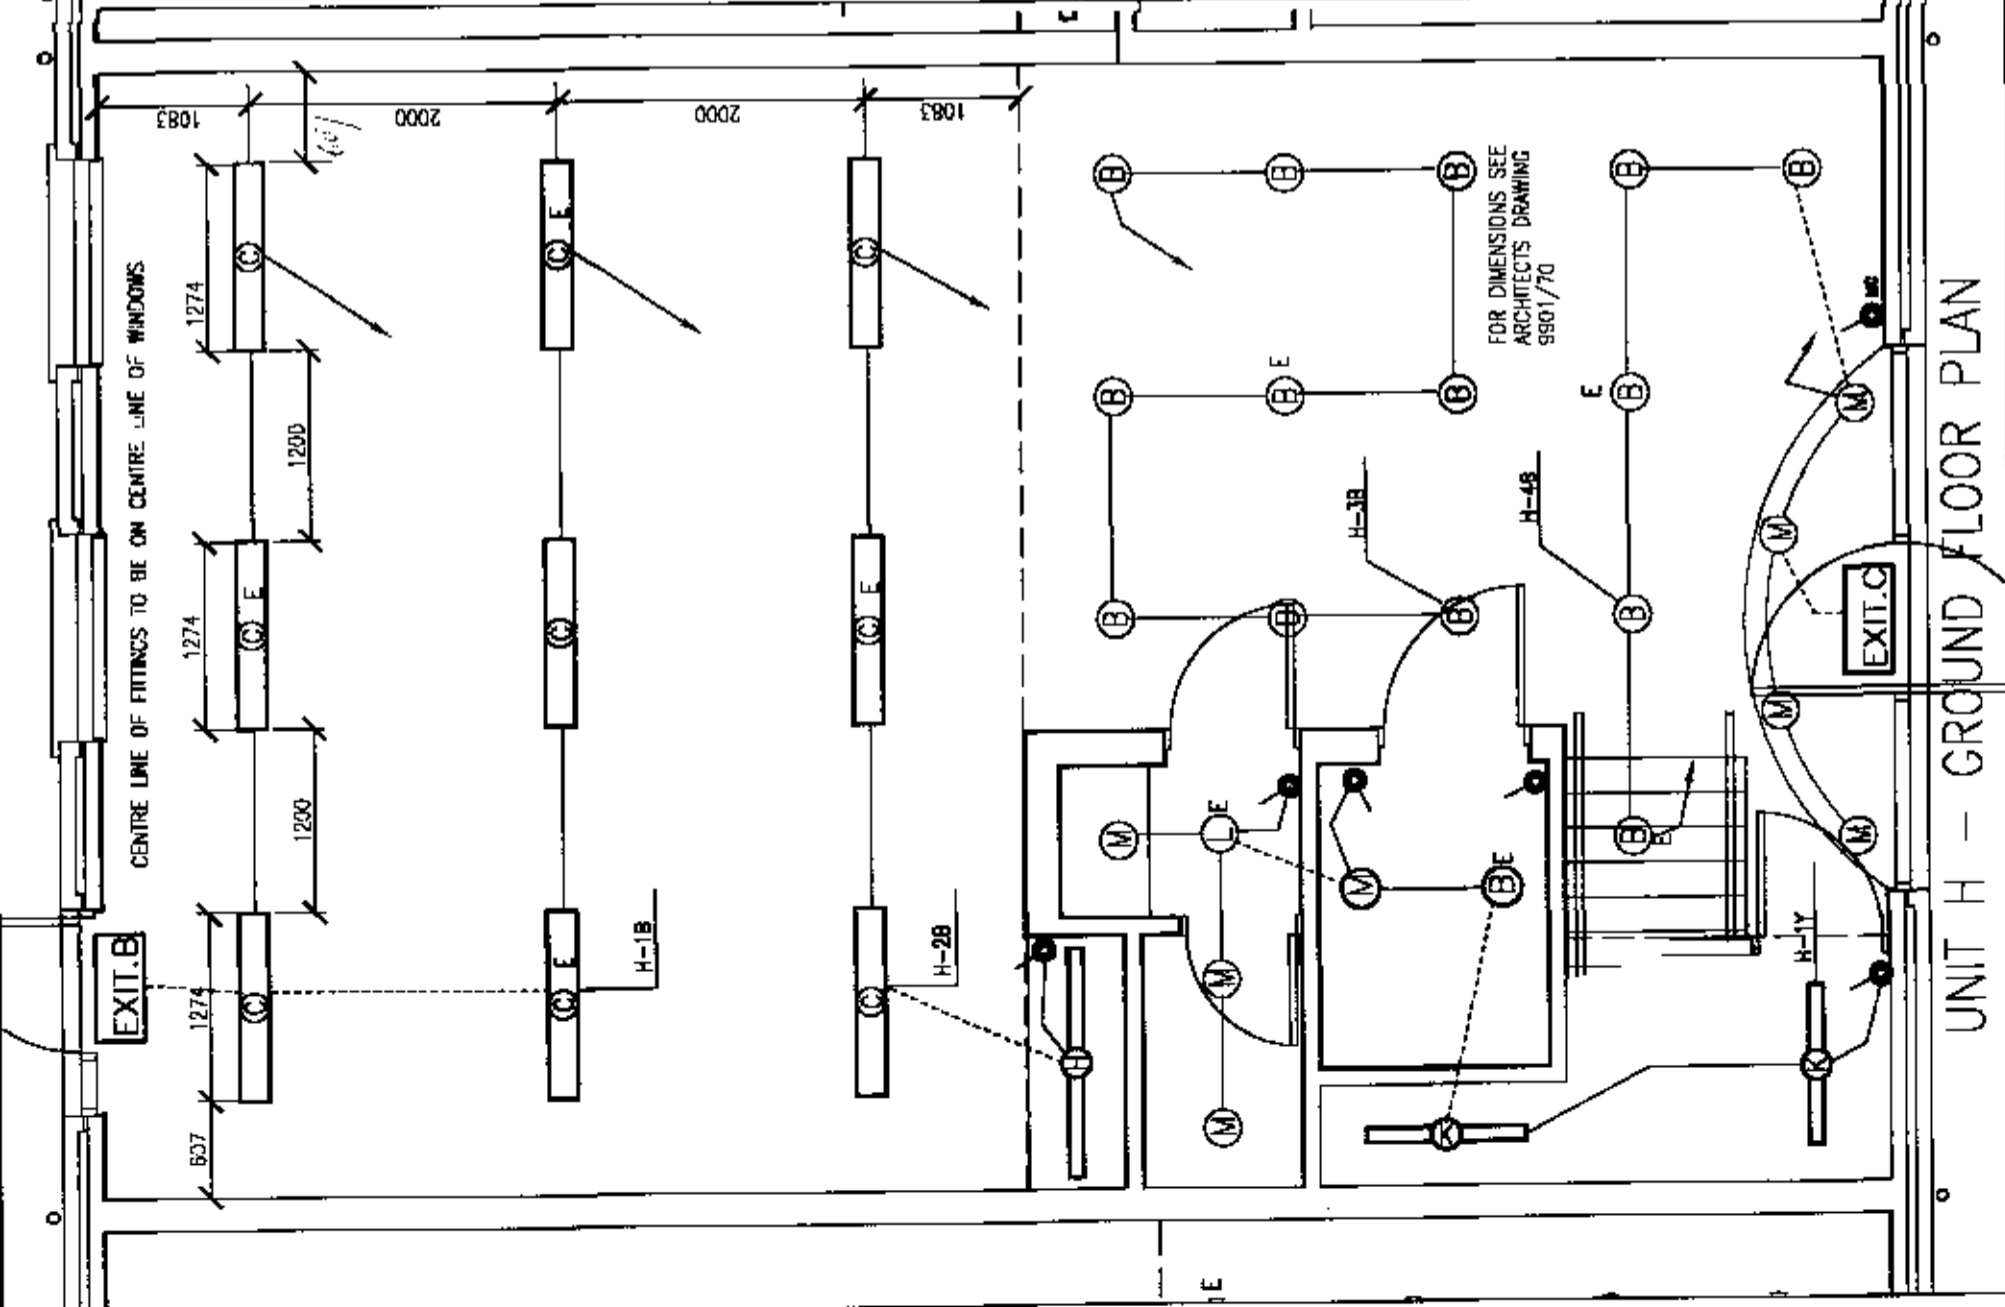

UNIT H - GROUND FLOOR PLAN

<p>BRUNEL ENGINEERING CONSULTANTS LTD 1 Gloucester Row Clifton Bristol BS8 4AW TN 017 973 0835 FX 0117 873 1897</p>	<p>REEDSPACE LIMITED PROPOSED OFFICE DEVELOPMENT EASTERN ROAD, BRACKNELL</p>	<p>TENDER/CONTRACT Date: DEC 2000 Scale: 1:50 Drawing Number B193/H/K/G/F/E2</p>
-----------------------------------------------------------------------------------------------------------------------------------------	--------------------------------------------------------------------------------------	----------------------------------------------------------------------------------------------

25.1.02

UNIT H & K - GROUND FLOOR LIGHTING SERVICES