

Rev.	Date	Revisions
1	15.03.00	ISSUE FOR TENDER AND 2 No. OF SETS FOR CONSTRUCTION
2	15.03.00	ISSUE FOR TENDER AND 2 No. OF SETS FOR CONSTRUCTION
3	15.03.00	ISSUE FOR TENDER AND 2 No. OF SETS FOR CONSTRUCTION
4	15.03.00	ISSUE FOR TENDER AND 2 No. OF SETS FOR CONSTRUCTION
5	15.03.00	ISSUE FOR TENDER AND 2 No. OF SETS FOR CONSTRUCTION
6	15.03.00	ISSUE FOR TENDER AND 2 No. OF SETS FOR CONSTRUCTION
7	15.03.00	ISSUE FOR TENDER AND 2 No. OF SETS FOR CONSTRUCTION
8	15.03.00	ISSUE FOR TENDER AND 2 No. OF SETS FOR CONSTRUCTION
9	15.03.00	ISSUE FOR TENDER AND 2 No. OF SETS FOR CONSTRUCTION
10	15.03.00	ISSUE FOR TENDER AND 2 No. OF SETS FOR CONSTRUCTION


BRUNEL
 ENGINEERING CONSULTANTS LTD
 1 Gloucester Row
 Clifton
 Bristol BS8 4AW
 TN. 0117 973 0635 FX. 0117 973 1997

Contract
REEDSPACE LIMITED
 PROPOSED OFFICE DEVELOPMENT
 EASTERN ROAD, BRACKNELL

Drawing Title
UNIT 1 - FIRST FLOOR LIGHTING SERVICES
 10.4.02

Drawing Status
TENDER/CONTRACT

Date: DEC. 2000 Scale: 1:50
 Drawing Number: 9193/HFF/E2
 Rev. D

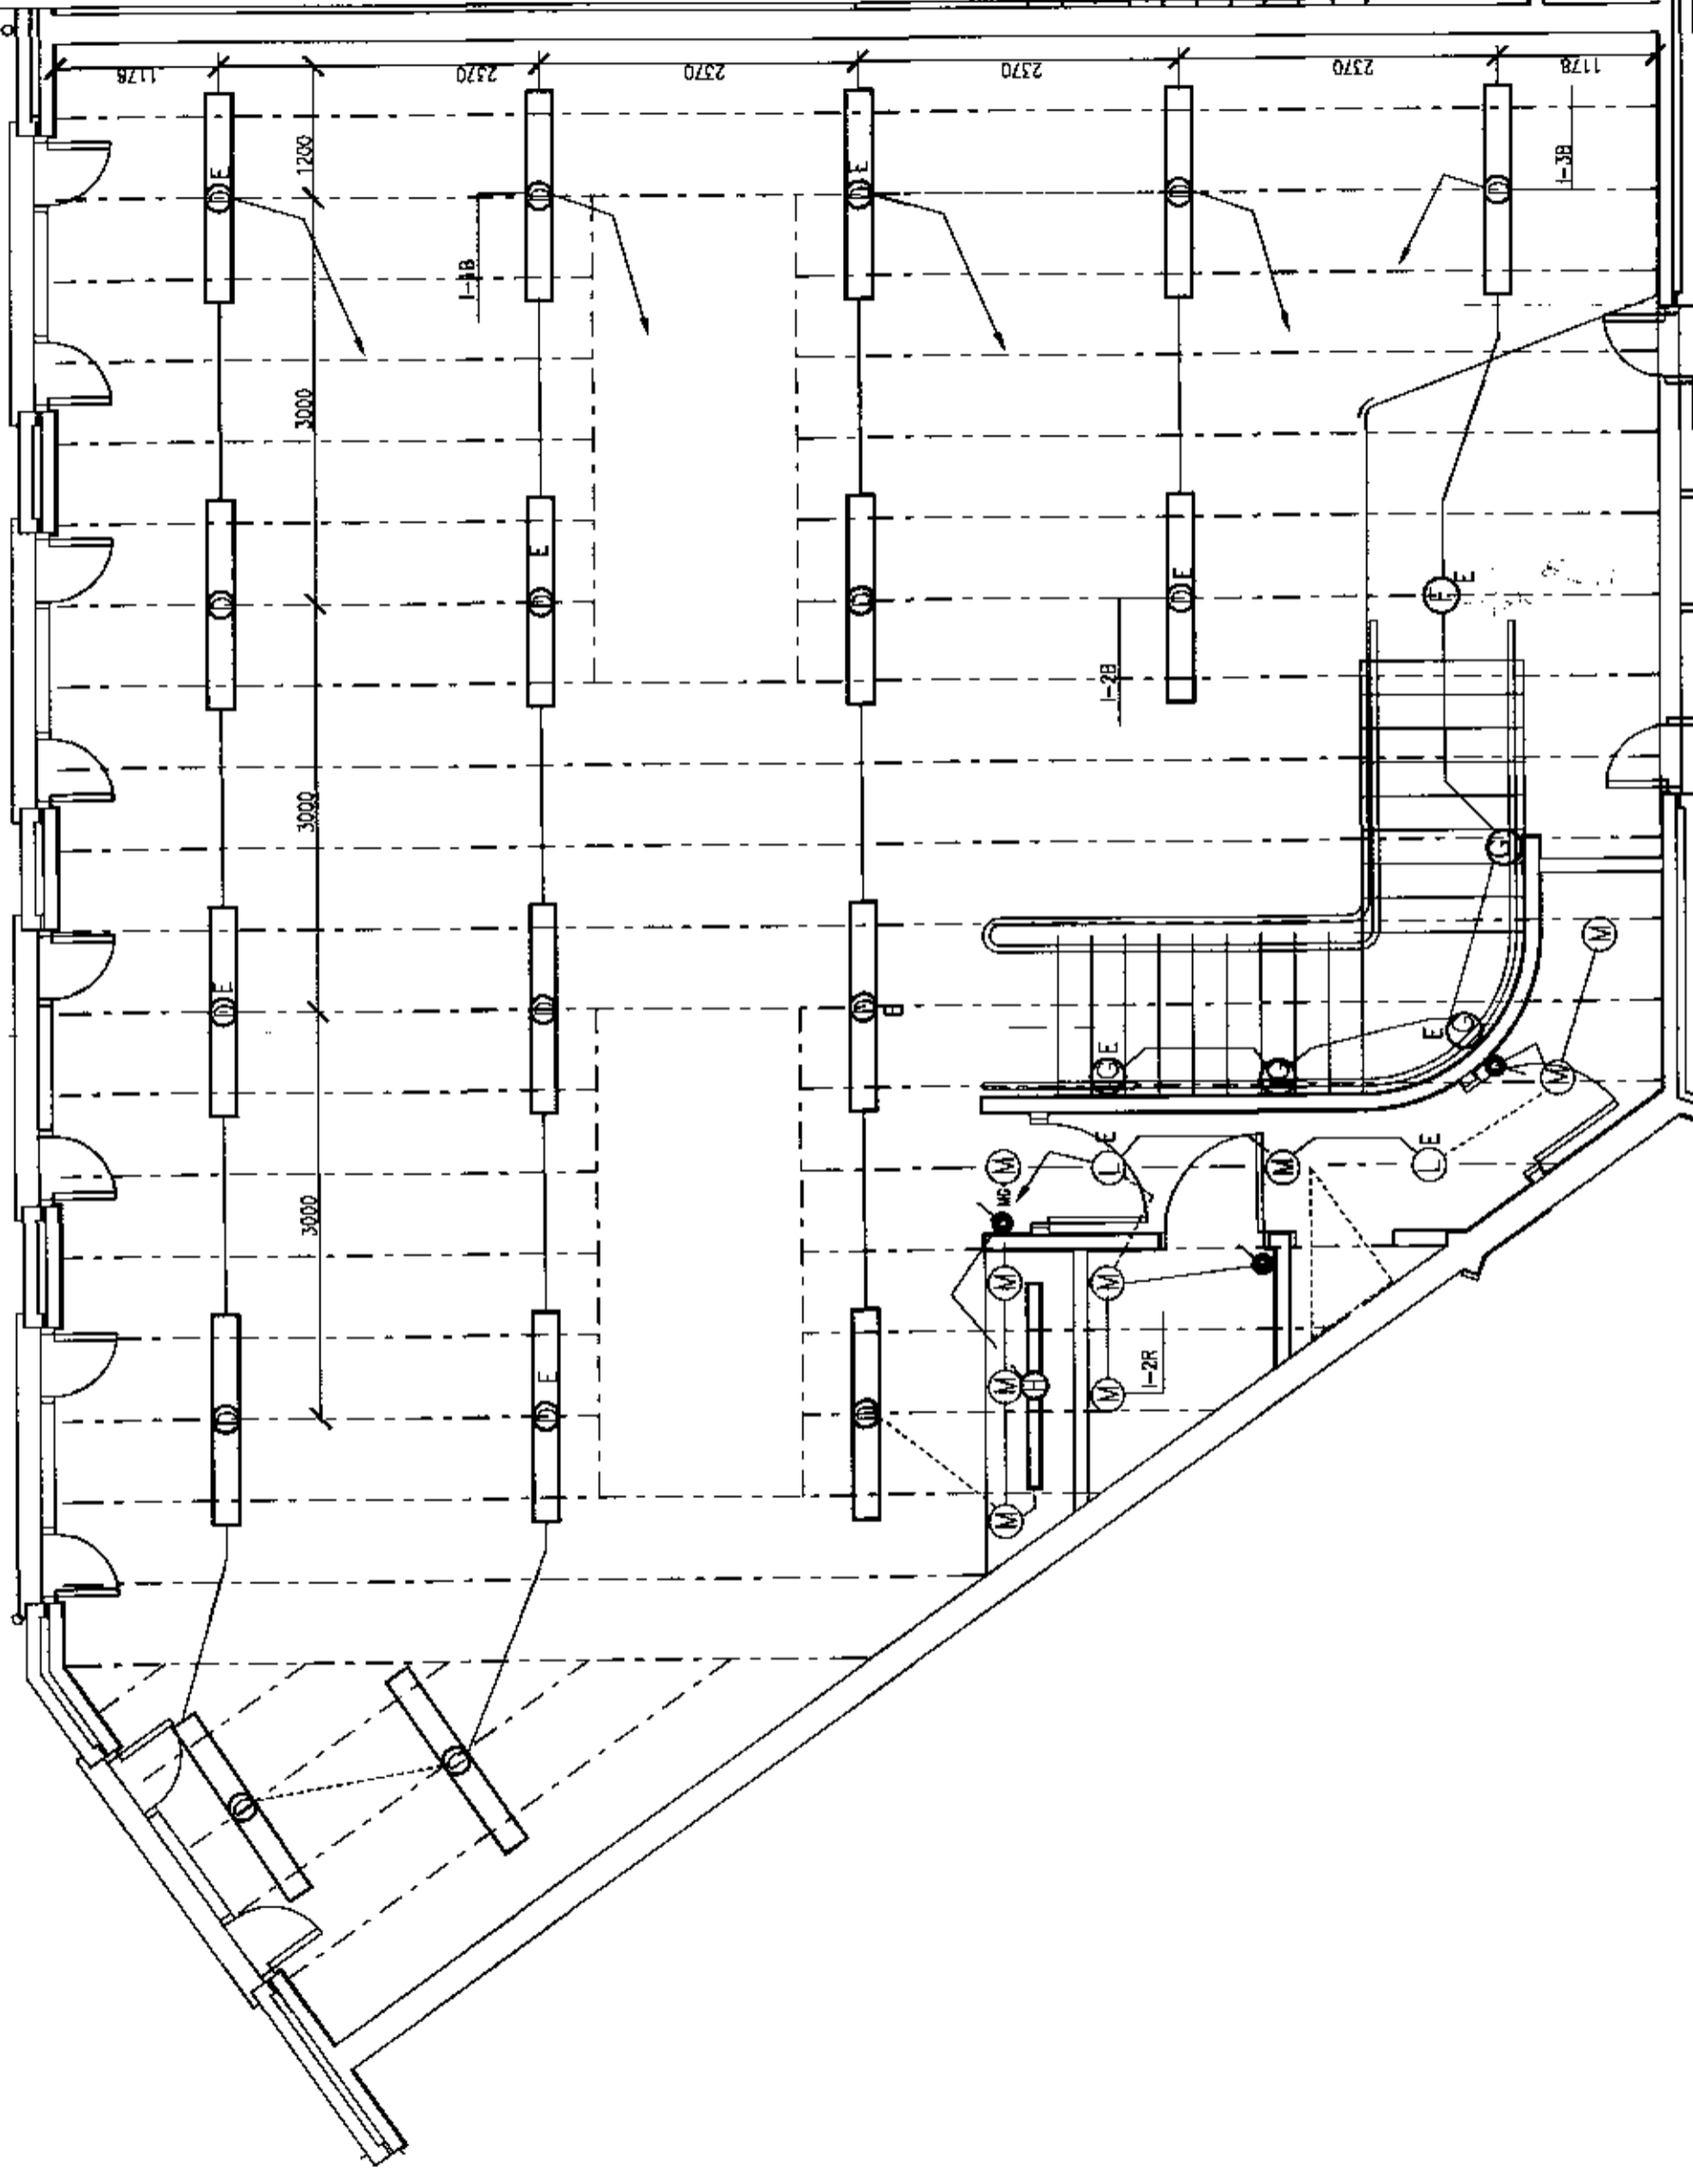

UNIT 1 - FIRST FLOOR PLAN