



CENTRE LINE OF FITTINGS TO BE ON CENTRE LINE OF WINDOWS

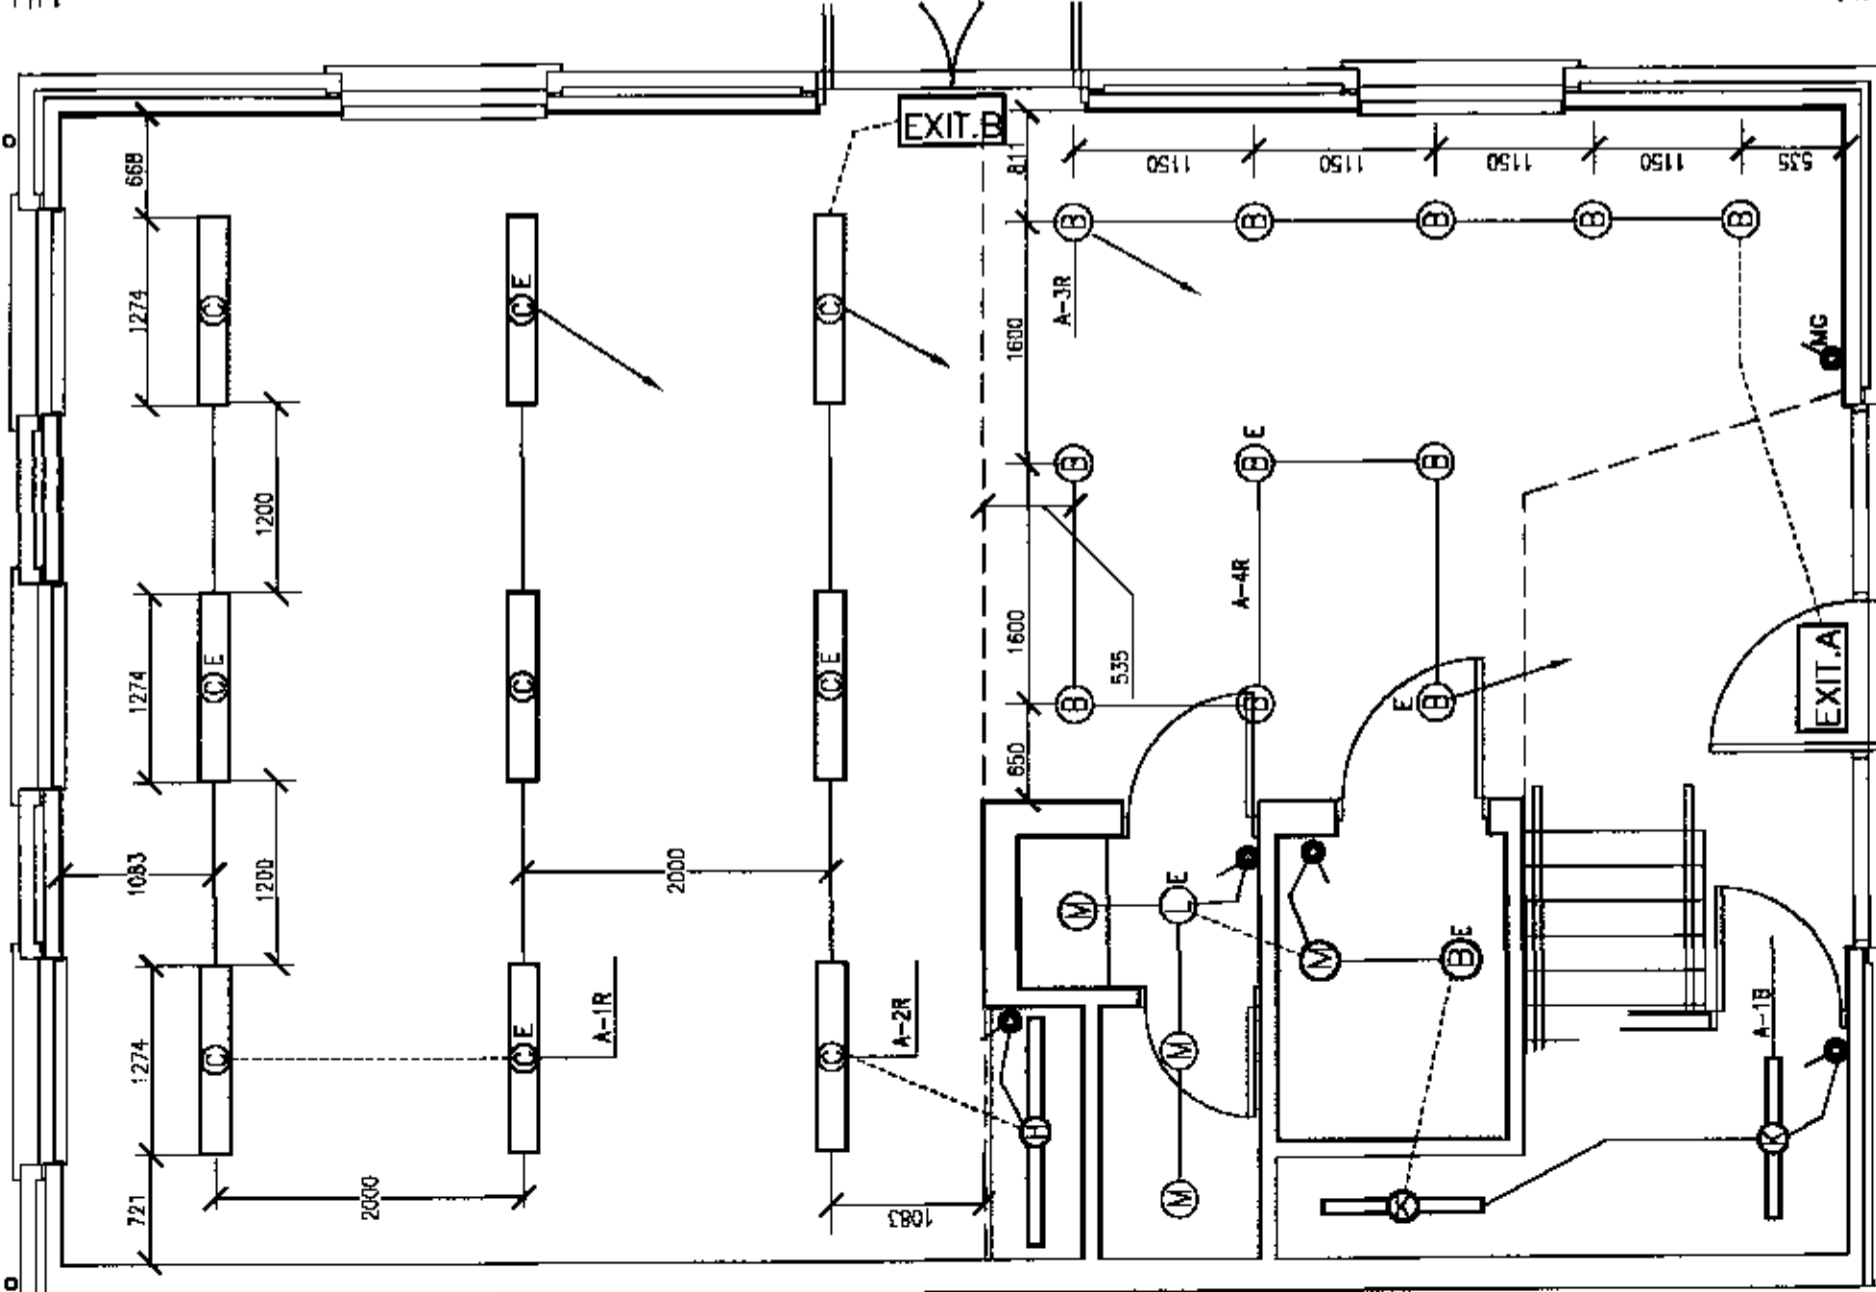

UNIT A - GROUND FLOOR PLAN

CENTRE LINE OF FITTINGS TO BE ON CENTRE LINE OF WINDOWS

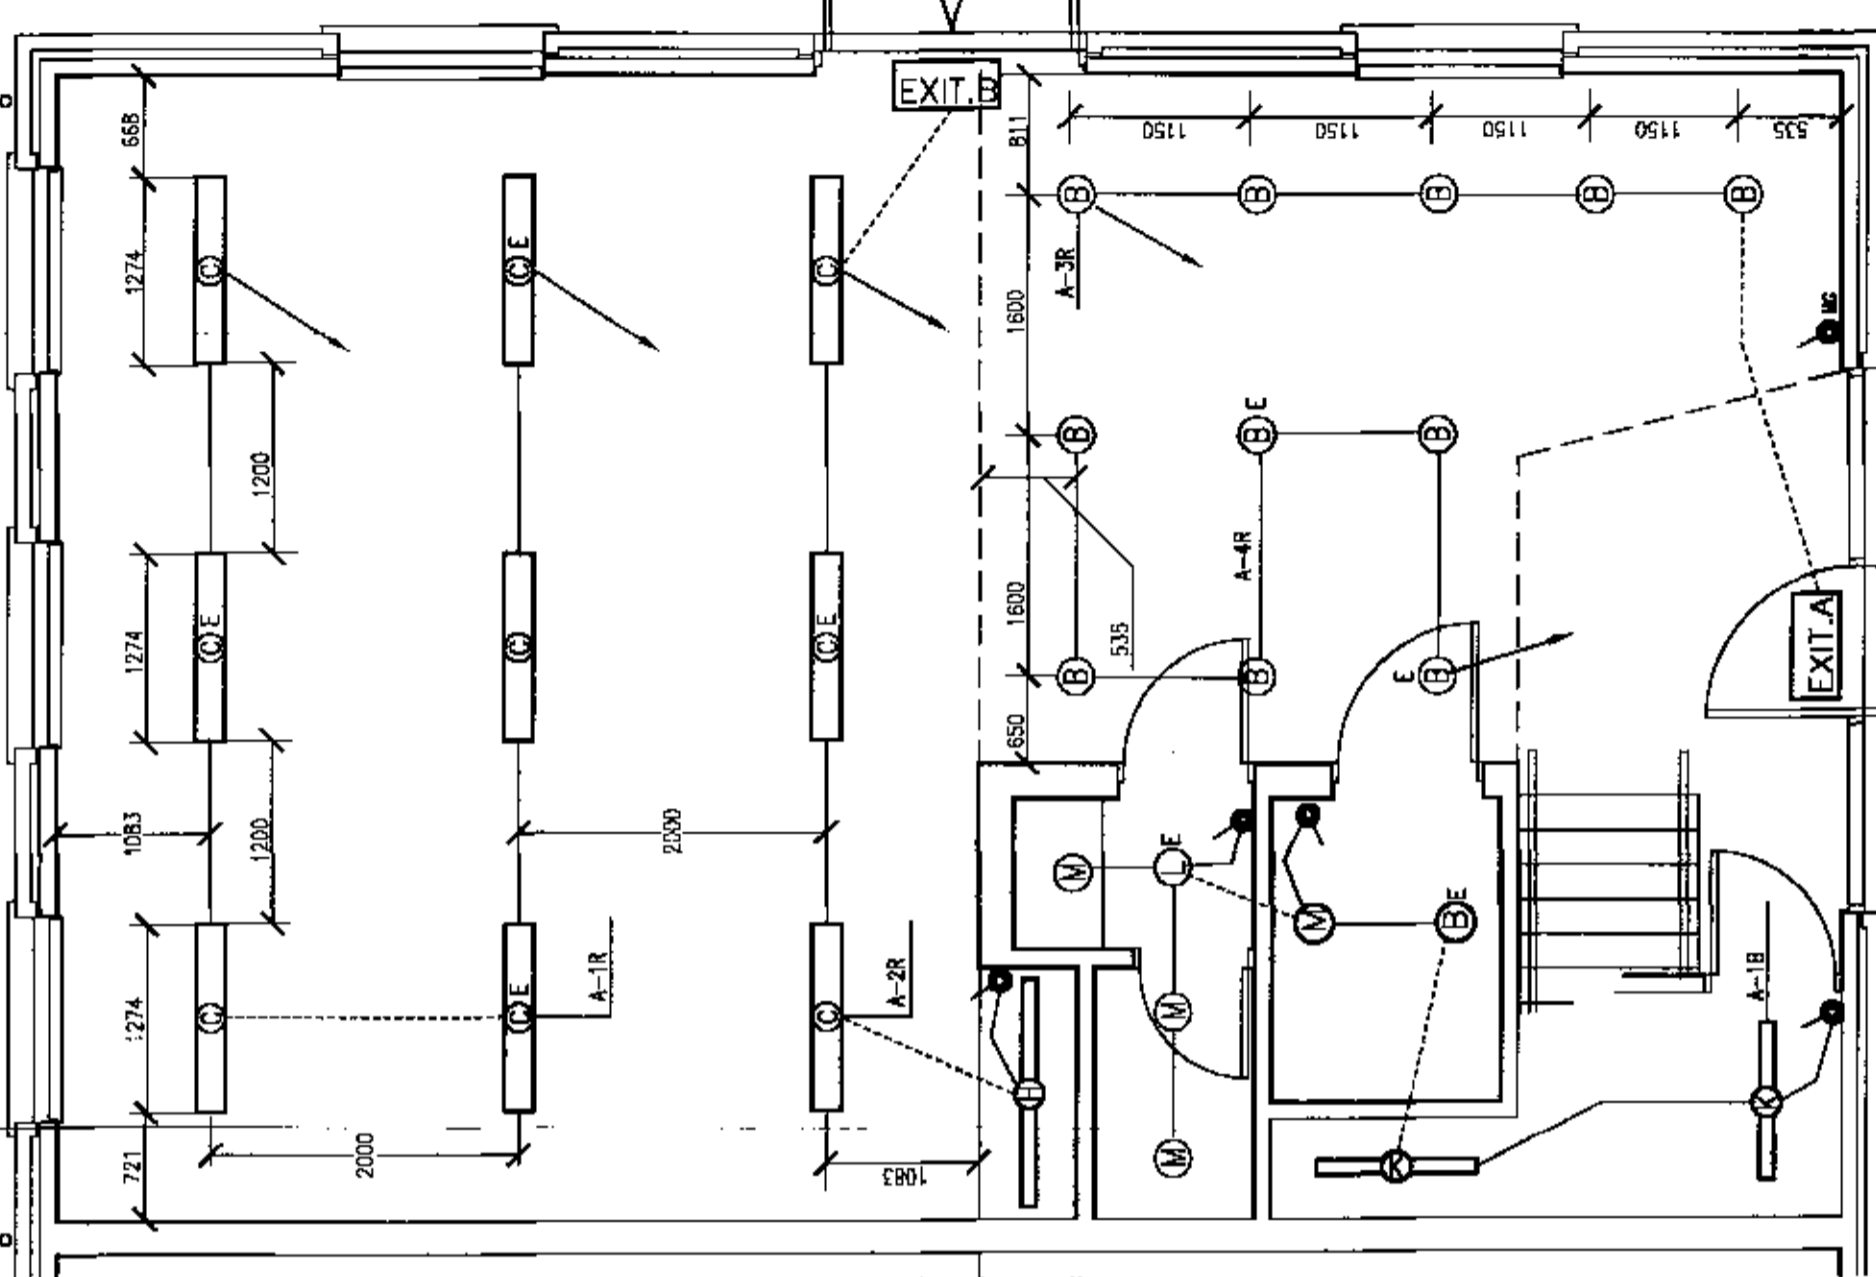

UNIT E - GROUND FLOOR PLAN

Rev.	Date	Revision
1	15.06.02	ISSUE FOR TENDER AND PERMITS
2	24.07.02	REVISIONS MADE TO TYPE N
3	27.07.02	REVISIONS MADE TO TYPE N
4	27.07.02	REVISIONS MADE TO TYPE N
5	27.07.02	REVISIONS MADE TO TYPE N
6	27.07.02	REVISIONS MADE TO TYPE N
7	27.07.02	REVISIONS MADE TO TYPE N
8	27.07.02	REVISIONS MADE TO TYPE N
9	27.07.02	REVISIONS MADE TO TYPE N
10	27.07.02	REVISIONS MADE TO TYPE N
11	27.07.02	REVISIONS MADE TO TYPE N
12	27.07.02	REVISIONS MADE TO TYPE N
13	27.07.02	REVISIONS MADE TO TYPE N
14	27.07.02	REVISIONS MADE TO TYPE N
15	27.07.02	REVISIONS MADE TO TYPE N
16	27.07.02	REVISIONS MADE TO TYPE N
17	27.07.02	REVISIONS MADE TO TYPE N
18	27.07.02	REVISIONS MADE TO TYPE N
19	27.07.02	REVISIONS MADE TO TYPE N
20	27.07.02	REVISIONS MADE TO TYPE N

BRUNEL
 ENGINEERING CONSULTANTS LTD
 1 Gloucester Row
 Clifton
 Bristol BS8 4AW
 TN 0117 973 0836 FX 0117 973 0897

Contract
REEDSPACE LIMITED
 PROPOSED OFFICE DEVELOPMENT
 EASTERN ROAD, BRACKNELL

Drawing Title
**UNITS A & E - GROUND FLOOR
 LIGHTING SERVICES**

1.2.02

Drawing Status
CONTRACT

Date: DEC 2000 Scale: 1:50
 Drawing Number
9193/A-E/GF/E2

D